




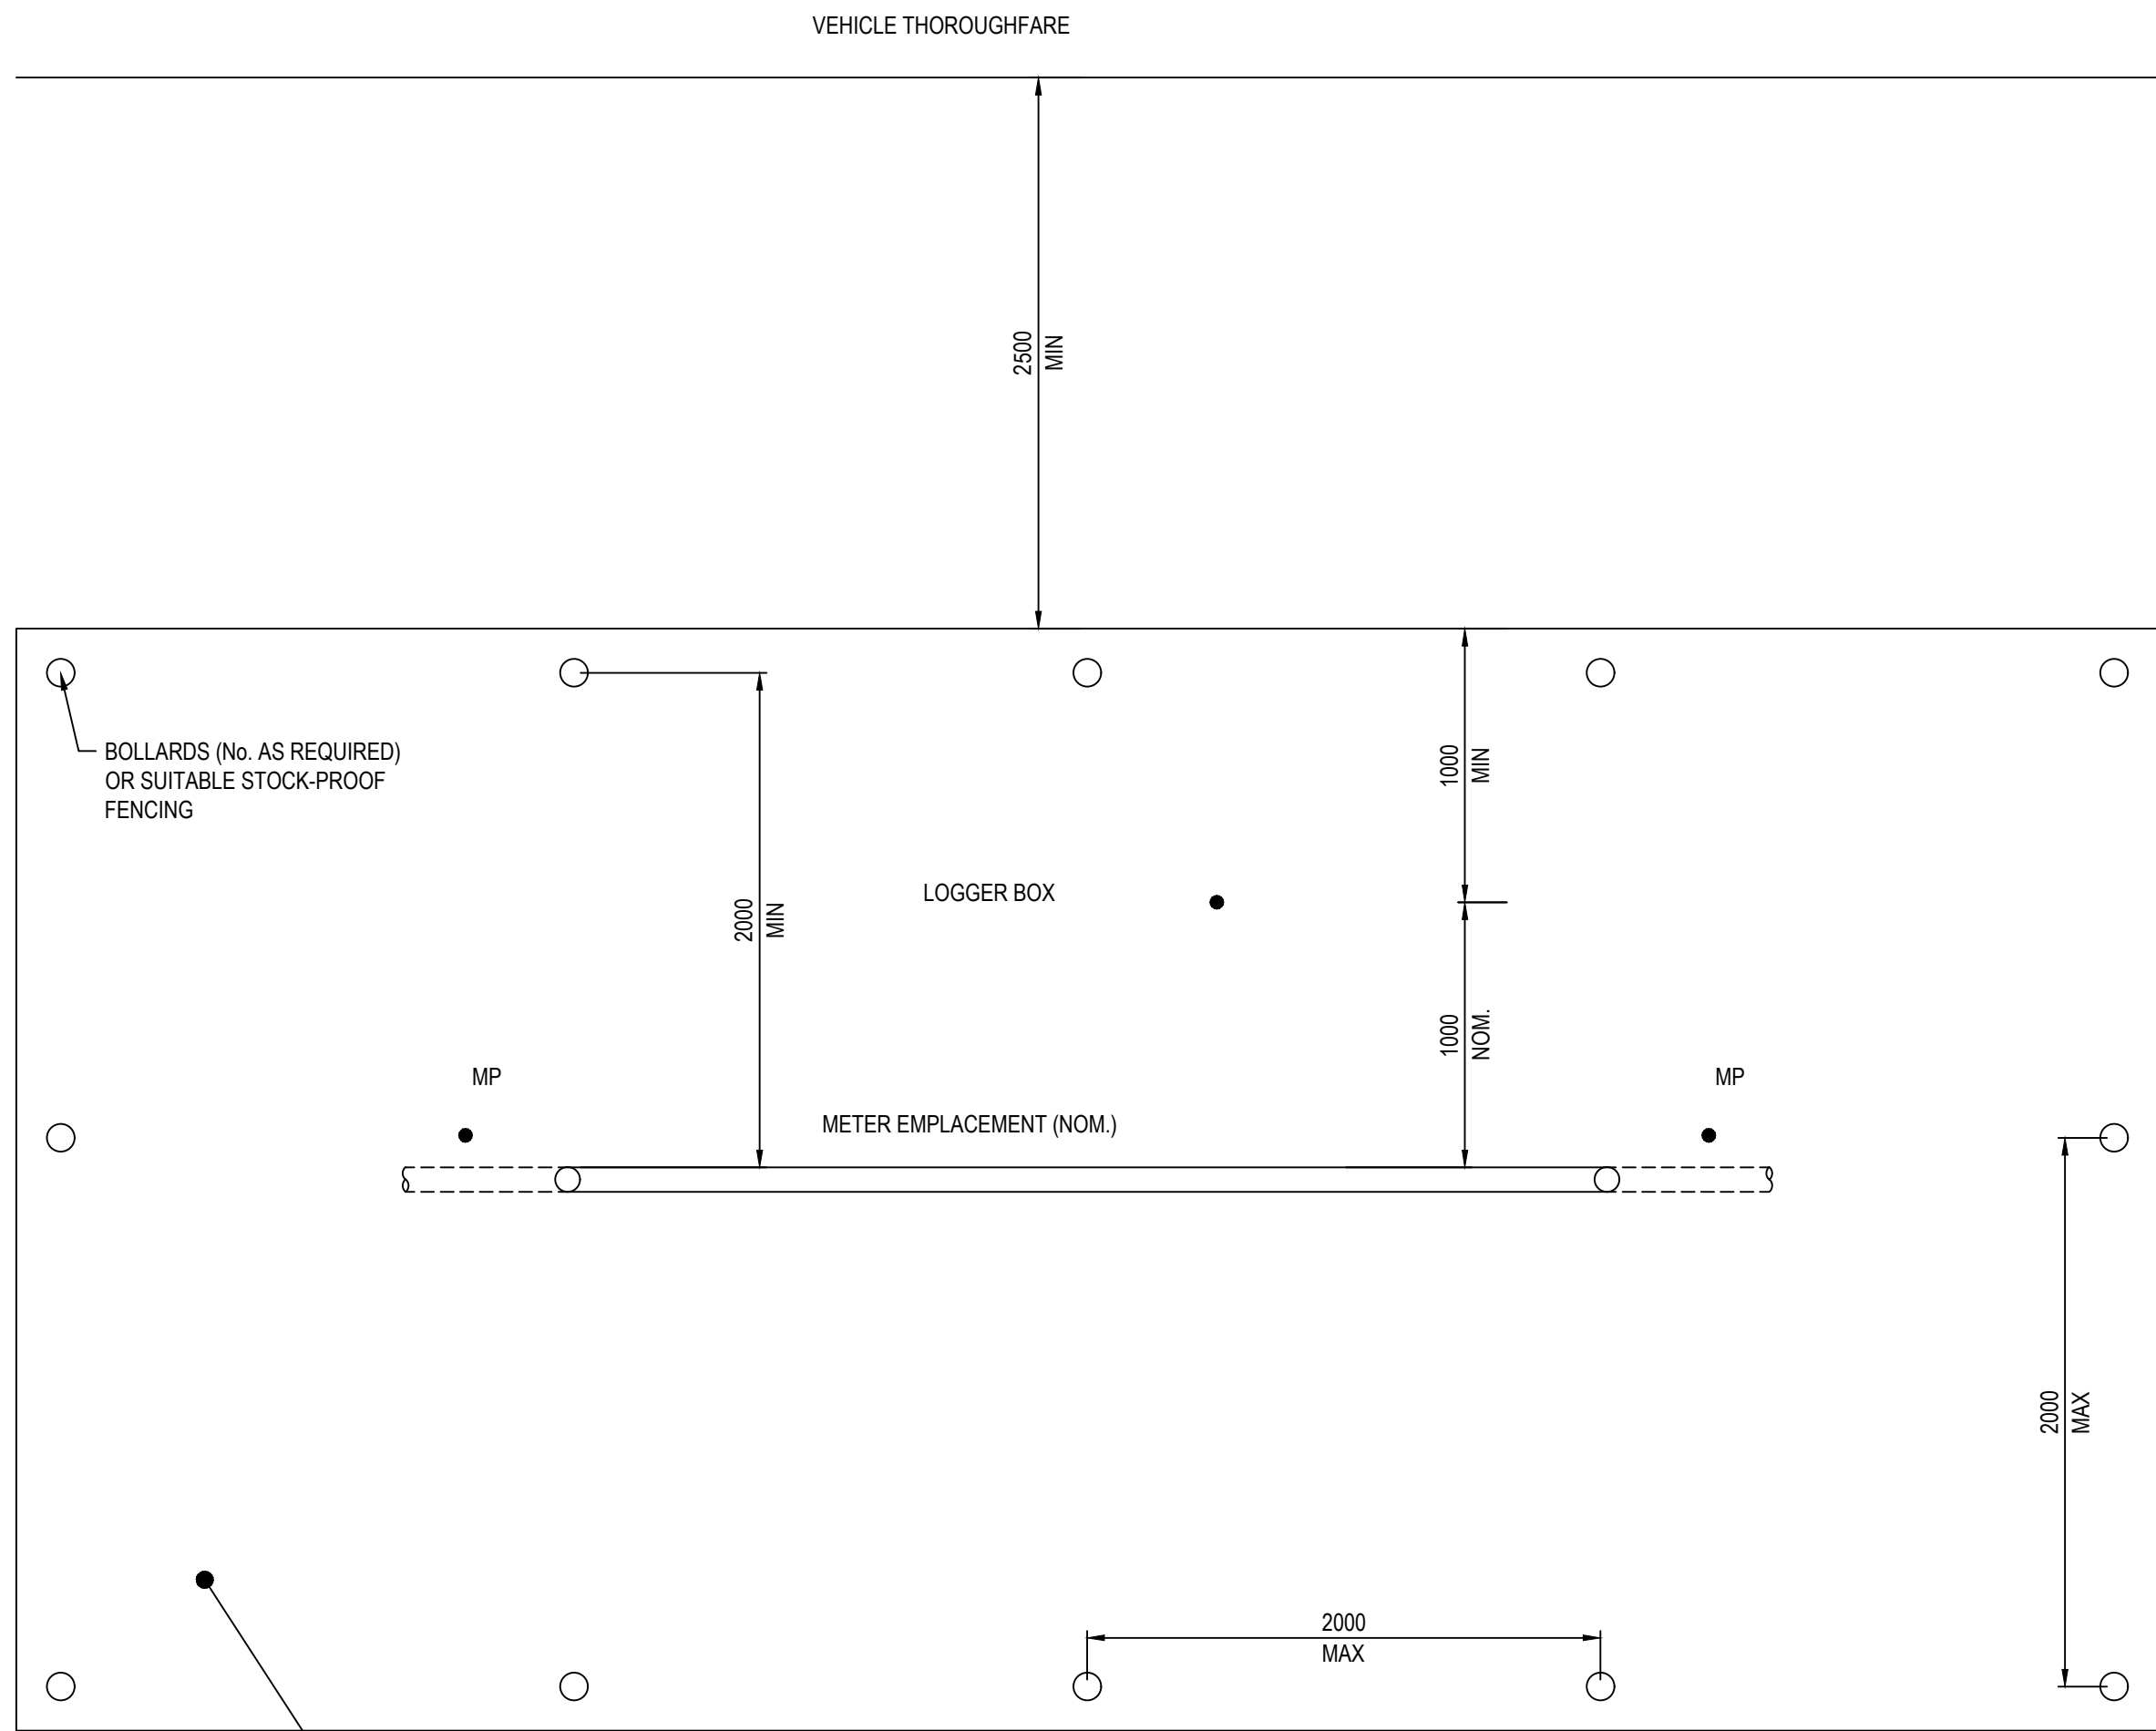


SITE PLAN
NOT TO SCALE

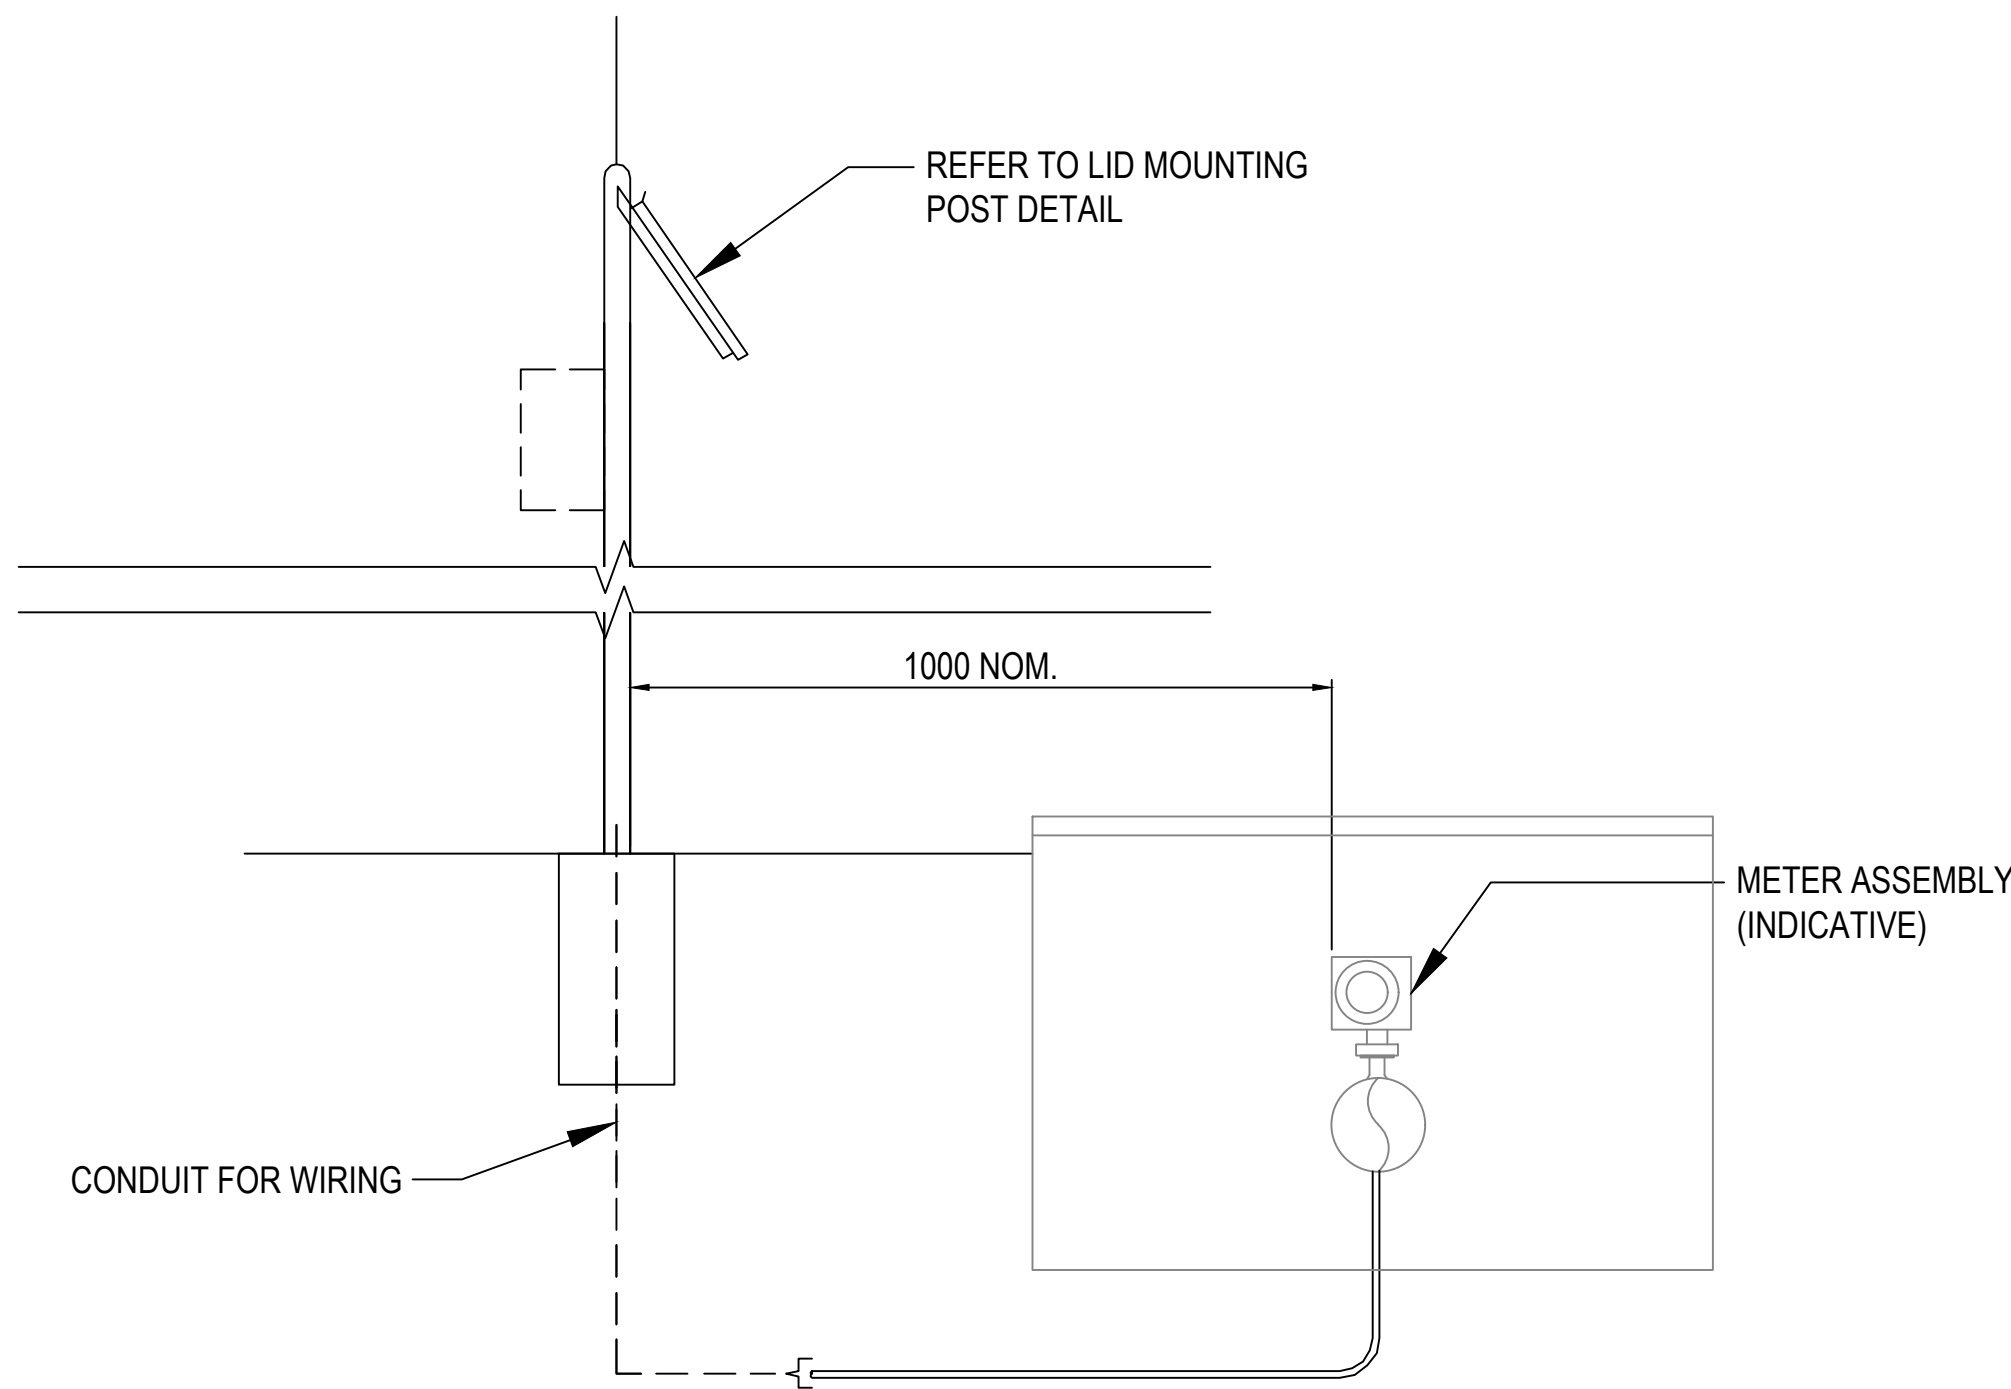

LID BELOW GROUND ASSEMBLY
NOT TO SCALE

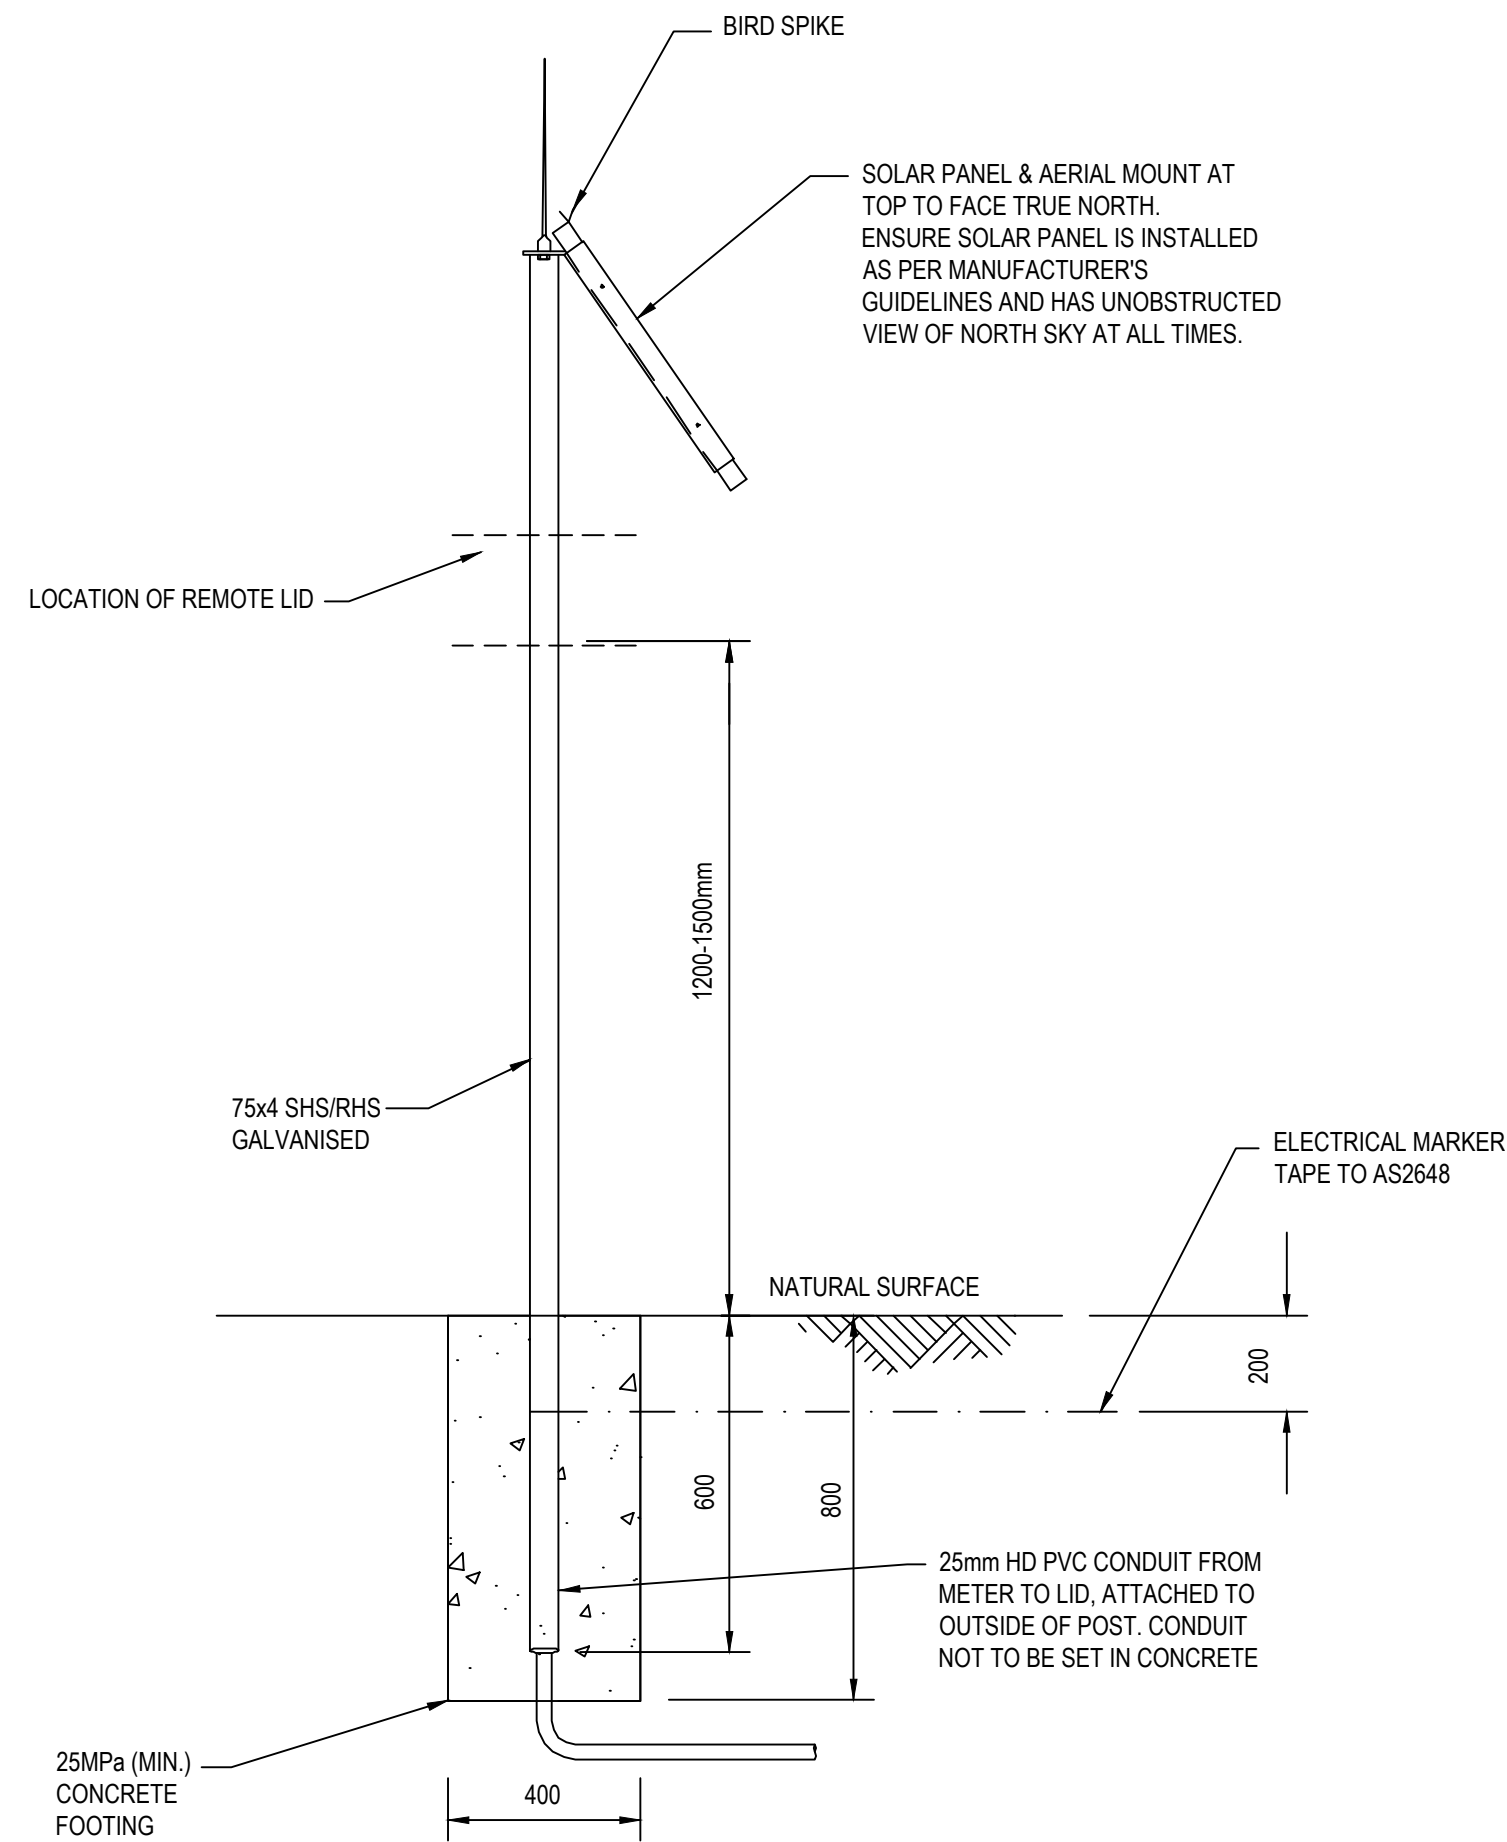

LID MOUNTING POST
NOT TO SCALE

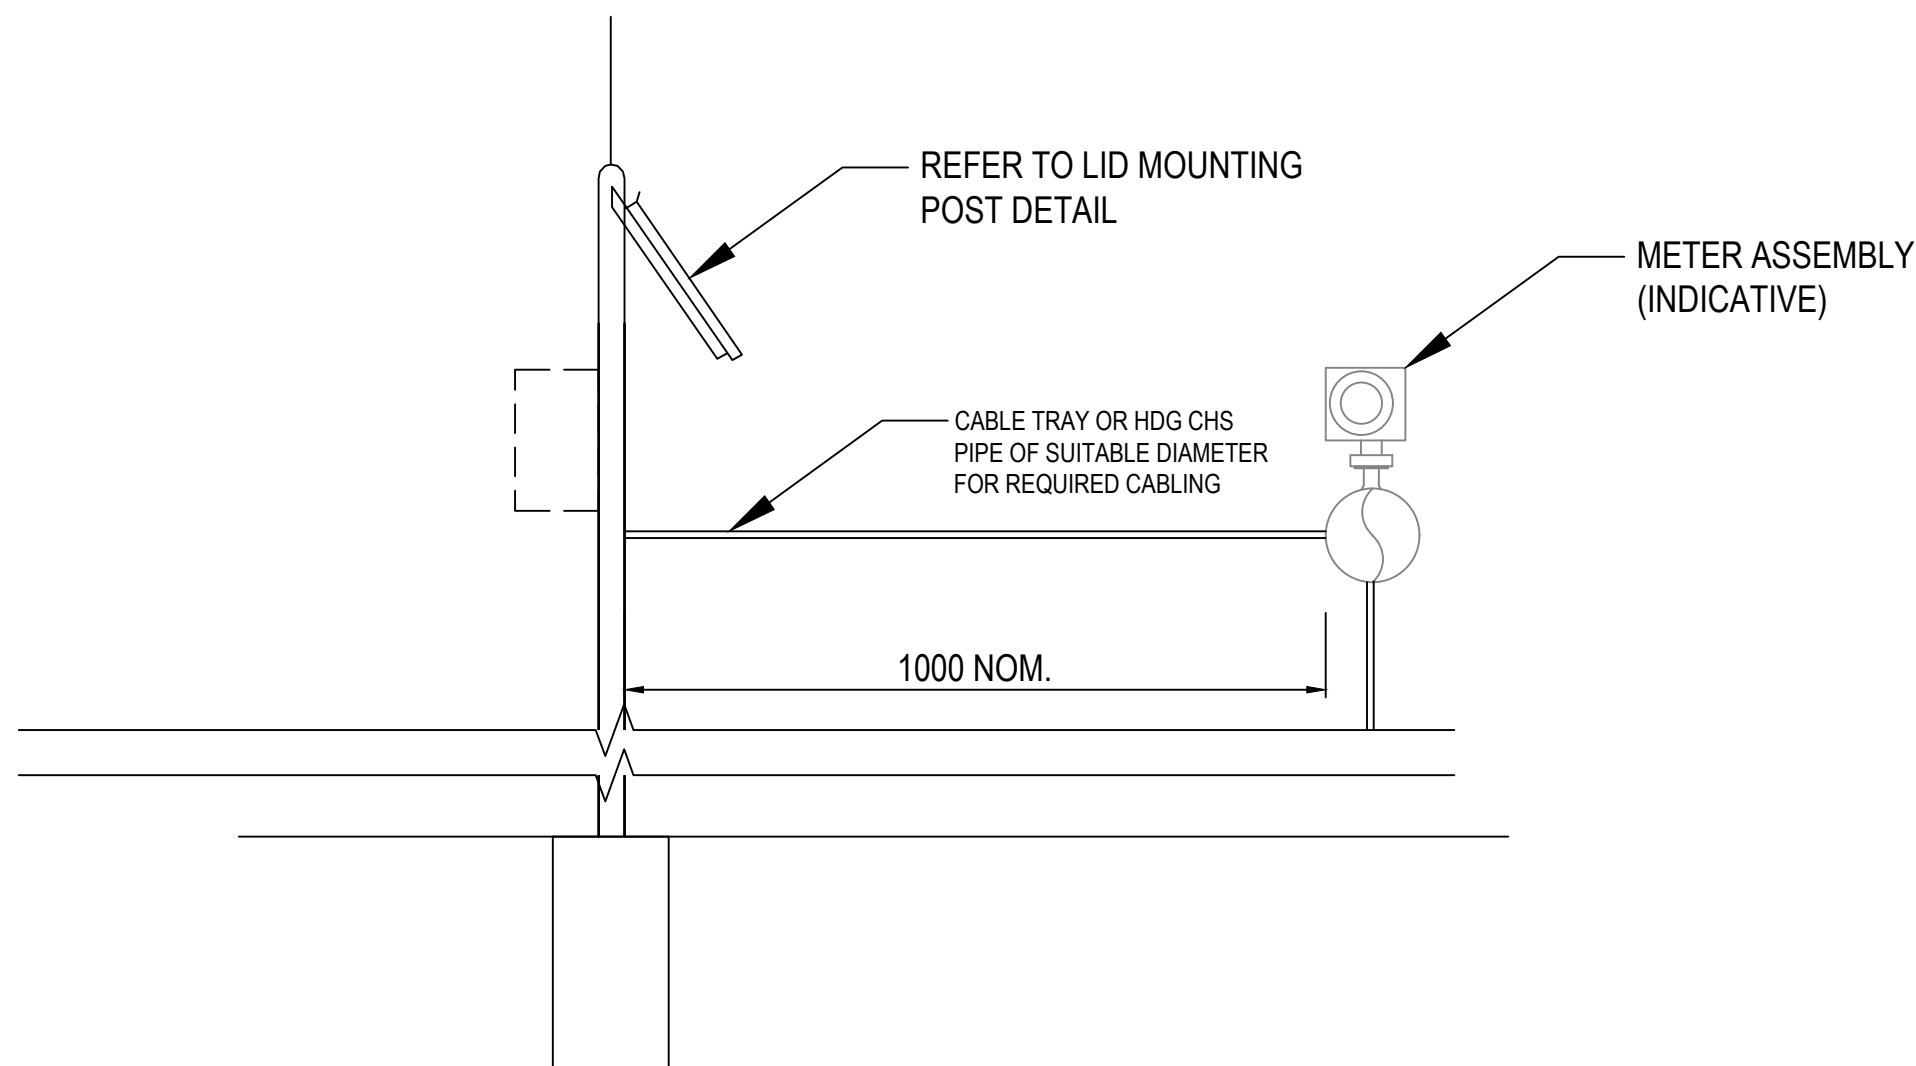

LID ABOVE GROUND ASSEMBLY
NOT TO SCALE

- NOTES:
- THE DRAWINGS AND CHECKLISTS ARE GUIDELINES ONLY AND INDICATIVE OF THE RECOMMENDED BEST-PRACTICES THAT SHOULD BE CONSIDERED DURING METER INSTALLATION. THESE DRAWINGS ARE NOT TO SCALE, AND ANY INSTALLATION WILL NEED TO BE MODIFIED TO MEET SITE CONDITIONS.
 - ITEMS SHADED GREY ARE INDICATIVE ONLY AND NON-PRESCRIPTIVE
 - STANDARD DRAWINGS APPLICABLE TO DN100 - DN600 METERS ONLY. METERS > DN600 REQUIRE SITE-SPECIFIC ENGINEERED DESIGNS.
 - UNITS ARE IN MILLIMETRES U.N.O.
 - RECOMMENDED PRINTING SIZE A3

			©2025 State of NSW and Department of Climate Change, Energy, the Environment and Water.					Client DEPARTMENT OF CLIMATE CHANGE, ENERGY, THE ENVIRONMENT & WATER			
			DCCEEW has compiled these standard diagrams for metering equipment (Diagrams) in good faith, exercising all due care and attention, to assist duly qualified persons and meter installers. No representation is made about the accuracy, completeness or suitability of the information for the context in which these Diagrams are used. DCCEEW will not be liable for any loss or claim, including any death or injury to people, loss of income, penalties or damage to property arising from the use of these Diagrams to install metering equipment or otherwise. Users of the Diagrams should seek appropriate advice for their specific needs, or those of their customers, when using the Diagrams.					Project NON-URBAN WATER METERING - STANDARD DESIGNS		Status AN INSTALLATION GUIDE FOR DEMONSTRATION PURPOSES	
			© 2025 Crown in right of the State of NSW acting through the Department of Climate Change, Energy, the Environment and Water (DCCEEW). These Diagrams may be reproduced, adapted and distributed by third parties in accordance with the terms of the CC-BY-NC international creative commons licence version 4.0. Details of these licence terms are available at https://creativecommons.org/licenses/by-nc/4.0/ . In accordance with this licence, users may not charge any commercial fee when further distributing these Diagrams to third parties, must indicate clearly if the Diagrams have been modified, must attribute DCCEEW as copyright owner, and must retain these Terms of Use in full on all copies of these Diagrams.					Title LID ASSEMBLY & DETAILS ABOVE AND BELOW GROUND PUB25/512		Drawing Number 25026-CI-1007	
										Revision A	
A	31/01/25	FOR INFORMATION									
Rev.	Date	Description									